


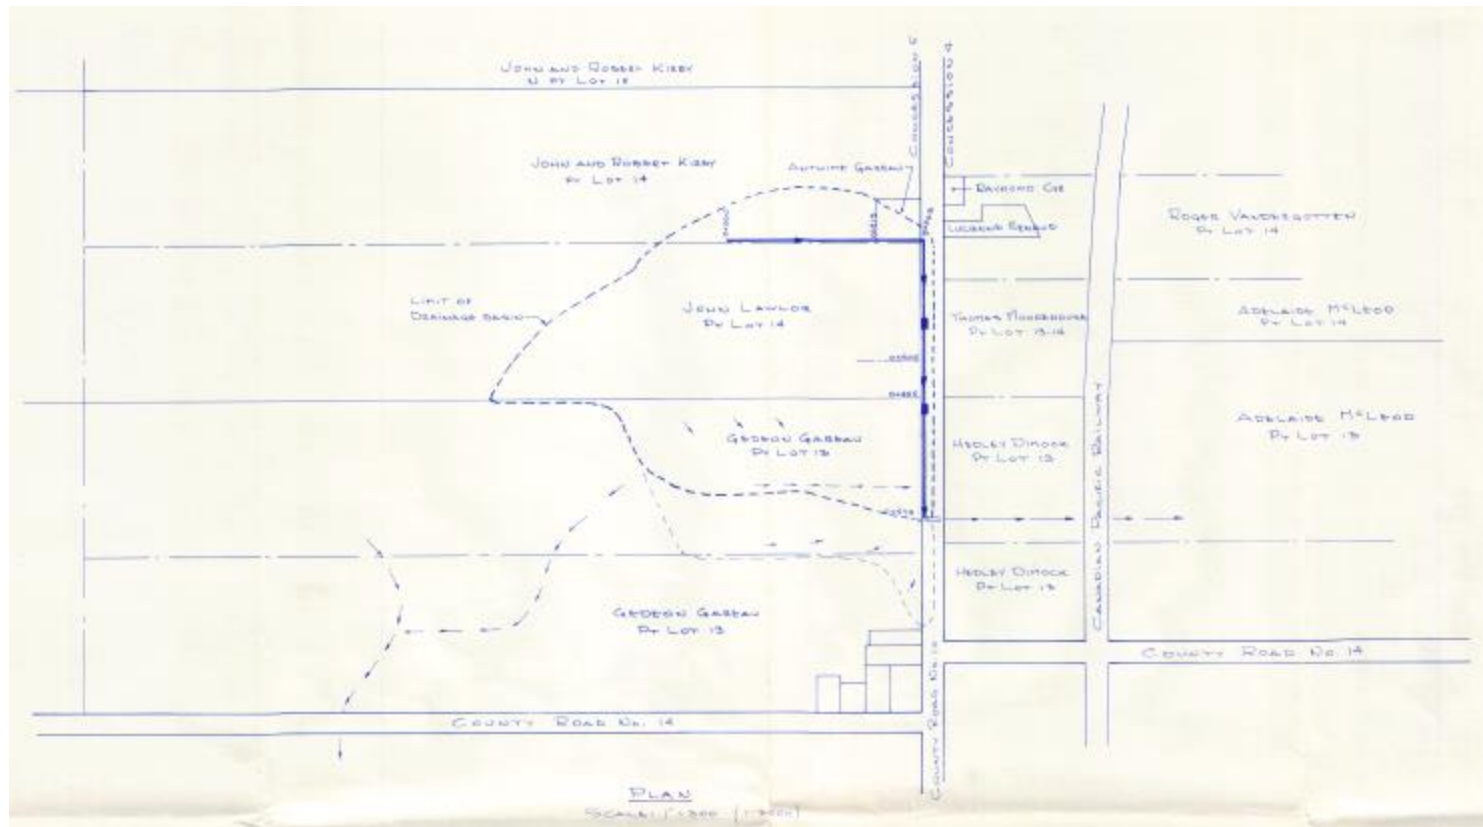

TOWNSHIP OF EAST HAWKESBURY		
PLAN AND PROFILE OF LITTLE JOHN MUNICIPAL DRAIN		
ANDRÉ E. DESJARDINS ENGINEERING LIMITED 614 THERIAULT STREET HAWKESBURY, ONTARIO		
DESIGN: A. DESJARDINS DATE: SEPTEMBER 1993	CONTRACT NO. H-8169	DRAWN: A.L. CHECKED: A.E.D.